




PACIFIC NAZARENE HOUSING SOCIETY

LANGLEY, BC

AD	Area Drain	NG	Not in Contact
ALT	Alternate	NO	Number
ALUM	Aluminum	NTS	Not to Scale
ARCH	Architectural	OC	On Center
AVG	Average	OD	Outside Diameter/Dimension
B	Bottom	PC	Point of Curvature
BB	Bottom of Bench Elevation	PERP	Perpendicular
BC	Bottom of Curb Elevation	PA	Planting Area
BILD	Building	PI	Point of Intersection
BOL	Bolster	PL	Property Line
BP	Bottom of Pool	PLNT	Planting
BS	Bottom of Step Elevation	PO	Point of Origin
BTW	Between	PP	Protection Plate
BW	Bottom of Wall Elevation	PPR	Plaster/Plaster
CB	Catch Basin	PSI	Pounds per Square Inch
CD	Card	PT	Point of Tangency
CJ	Casted Joint	QTY	Quantity
CL	Centerline Joint	R	Radius
COMP	Compacted	RA	Radius
CONC	Concrete	REBAR	Reinforcing Bar
DEG	Degree	REQ	Required
DRT	Drain	R/W	Right of Way
DB	Diameter	SB	Setback
DEM	Dimension	SH	Sheet
DN	Down	SPEC	Specifications
DWG	Drawing	SECT	Section
EJ	Expansion Joint	SG	Square
ENG	Engineer/Engineering	SS	Stainless Steel
EQ	Equal	STA PT	Station Point
EX	Existing	STD	Standard
FC	Finish Curb	STR	Structural
FDN	Foundation	STRUCTURE	Structure
FG	Finish Grade	T	Top
FIN	Finish	TE	Top of Bench Elevation
FTG	Footing	TEB	Top and Bottom
FTN	Foundation	TEN	Temporary
QALV	Quarantined	TC	Top of Curb Elevation
HEF	Horizontal Each Face	TD	Trench Drain
HP	High Pressure	TEMP	Temporary
HT	Height	THK	Thick
HWL	High Water Level	TGS	Top of Gable
ID	Inside Diameter/Dimension	TPZ	Tree Protection Zone
INCL	Included Including	TS	Top of Step Elevation
J	Joint	TW	Top of Wall Elevation
LARCH	Landscape Architect	TYP	Typical
LOW	Level of Work	VERT	Vertical
LT	Light	VEF	Vertical Each Face
M	Material Notes	w/	with
MBX	Microton	w/o	without
MBN	Microton	WF	Water Feature
MBC	Microton	WJ	Water Jet
		WL	Water Level
		WP	Waterproofing

- GENERAL
1. L&L COVER PAGE
- LANDSCAPE ARCHITECTURAL DRAWINGS
2. L&L RENDERED PLAN & PRECEDENT IMAGES
3. L&L MATERIALS PLAN - GROUND LEVEL & LEVEL 2
4. L&L GRADING PLAN - GROUND LEVEL & LEVEL 2
5. L&L PLANTING PLAN - GROUND LEVEL & LEVEL 2
6. L&L PLANTING PLAN - GROUND LEVEL & LEVEL 2
7. L&L SCHEMATIC LIGHTING PLAN - GROUND LEVEL & LEVEL 2
8. L&L SECTIONS
9. L&L SECTIONS
10. L&L LANDSCAPE DETAILS
11. L&L LANDSCAPE DETAILS
12. L&L LANDSCAPE DETAILS

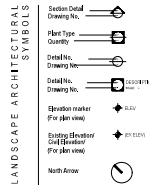

1. DO NOT SCALE DRAWINGS. USE DIMENSIONAL INFORMATION AS NOTED IN DRAWINGS. CONTACT THE LANDSCAPE ARCHITECT IMMEDIATELY IF THERE IS ANY AMBIGUITY, LACK OF INFORMATION OR INCONSISTENCY. REVISIONS FOR THIS NOTE AND EXTRA COSTS INCURRED WILL NOT BE ACCEPTED.
2. LANDSCAPE DRAWINGS ARE TO BE READ IN CONJUNCTION WITH ARCHITECTURAL AND ENGINEERING DRAWINGS. REPORT ANY DISCREPANCIES TO THE CONSULTANT FOR REVIEW AND RESPONSE.
3. ALL LINES AND DIMENSIONS ARE PARALLEL OR PERPENDICULAR TO THE LINES. DIMENSIONS ARE MEASURED PERPENDICULAR UNLESS NOTED OTHERWISE.
4. UTILITY AND LIGHTING ARE INDICATED FOR REFERENCE ONLY. REFER TO ENG. DRAWINGS FOR LOCATIONS, DETAILS, AND SPECIFICATIONS.
5. REFER TO ENGINEERING DRAWINGS FOR SUBGRADE, AND REINFORCING OF ALL PAVED SURFACES IN ROADWAYS.
6. PROVIDE PERIMETER FOR ALL ON-SITE SOFT LANDSCAPING INCLUDING TREES, SHRUBS, PERENNIALS, GRASSES AND GREENROOF.
7. PROVIDE ADEQUATE SUB-SURFACE DRAINAGE IN ALL PLANTED AREAS.
8. SEE CIVIL AND ARCHITECTURAL DRAWINGS FOR BUILDING PERIMETER AND ROADWAY GRADING.
9. ALL PLANT MATERIAL AND LANDSCAPE CONSTRUCTION TO CONFORM TO CSA STANDARDS.
10. ENSURE POSITIVE DRAINAGE.
11. PERIMETER ROADWAY TO BE RECONSTRUCTED FULLY IF DAMAGE.

CONSENT REQUIRED

This plan and design are, and it shall remain the exclusive property of PFS Studio and cannot be used or reproduced without written consent. Contractors shall verify and be responsible for all dimensions and conditions on the job. The client shall be responsible for any discrepancies from the drawings and conditions on the job.

NO.	DATE	DESCRIPTION	BY
1	NOV 06, 2024	DESIGN FOR COST ESTIMATE	MB
2	NOV 06, 2024	DESIGN FOR PERMITTING	MB
3	NOV 06, 2024	DESIGN FOR PERMITTING	MB
4	NOV 06, 2024	DESIGN FOR PERMITTING	MB
5	NOV 06, 2024	DESIGN FOR PERMITTING	MB
6	NOV 06, 2024	DESIGN FOR PERMITTING	MB
7	NOV 06, 2024	DESIGN FOR PERMITTING	MB
8	NOV 06, 2024	DESIGN FOR PERMITTING	MB
9	NOV 06, 2024	DESIGN FOR PERMITTING	MB
10	NOV 06, 2024	DESIGN FOR PERMITTING	MB
11	NOV 06, 2024	DESIGN FOR PERMITTING	MB
12	NOV 06, 2024	DESIGN FOR PERMITTING	MB
13	NOV 06, 2024	DESIGN FOR PERMITTING	MB
14	NOV 06, 2024	DESIGN FOR PERMITTING	MB
15	NOV 06, 2024	DESIGN FOR PERMITTING	MB
16	NOV 06, 2024	DESIGN FOR PERMITTING	MB
17	NOV 06, 2024	DESIGN FOR PERMITTING	MB
18	NOV 06, 2024	DESIGN FOR PERMITTING	MB
19	NOV 06, 2024	DESIGN FOR PERMITTING	MB
20	NOV 06, 2024	DESIGN FOR PERMITTING	MB



STAMP



PROJECT NAME
PACIFIC NAZARENE
HOUSING SOCIETY

 
DRAWING TITLE
COVER
PAGE

PFS PROJECT NUMBER: DATE:
24052 NOV 06/2024

DRAWN BY: CHECKED BY:
YY NM

SCALE
N/A

DWG. NO. OF:
L-0.0



PLAY STRUCTURES

EXPENSE			
Yr	Date	Grnt	R
1	NOV 06, 2004	GRANTED FOR BODY EXPENSE	00
2	NOV 08, 2004	GRANTED FOR ROUNDRING	00
3	DEC 02, 2004	GRANTED FOR ROUNDRING	00
4	JAN 05, 2005	GRANTED FOR ROUNDRING	00
5	JUN 13, 2005	GRANTED FOR ROUNDRING	00
6	MAY 19, 2005	GRANTED FOR ROUNDRING	00




PFS STUDIO

STAMP




DAY NO: _____

OF:

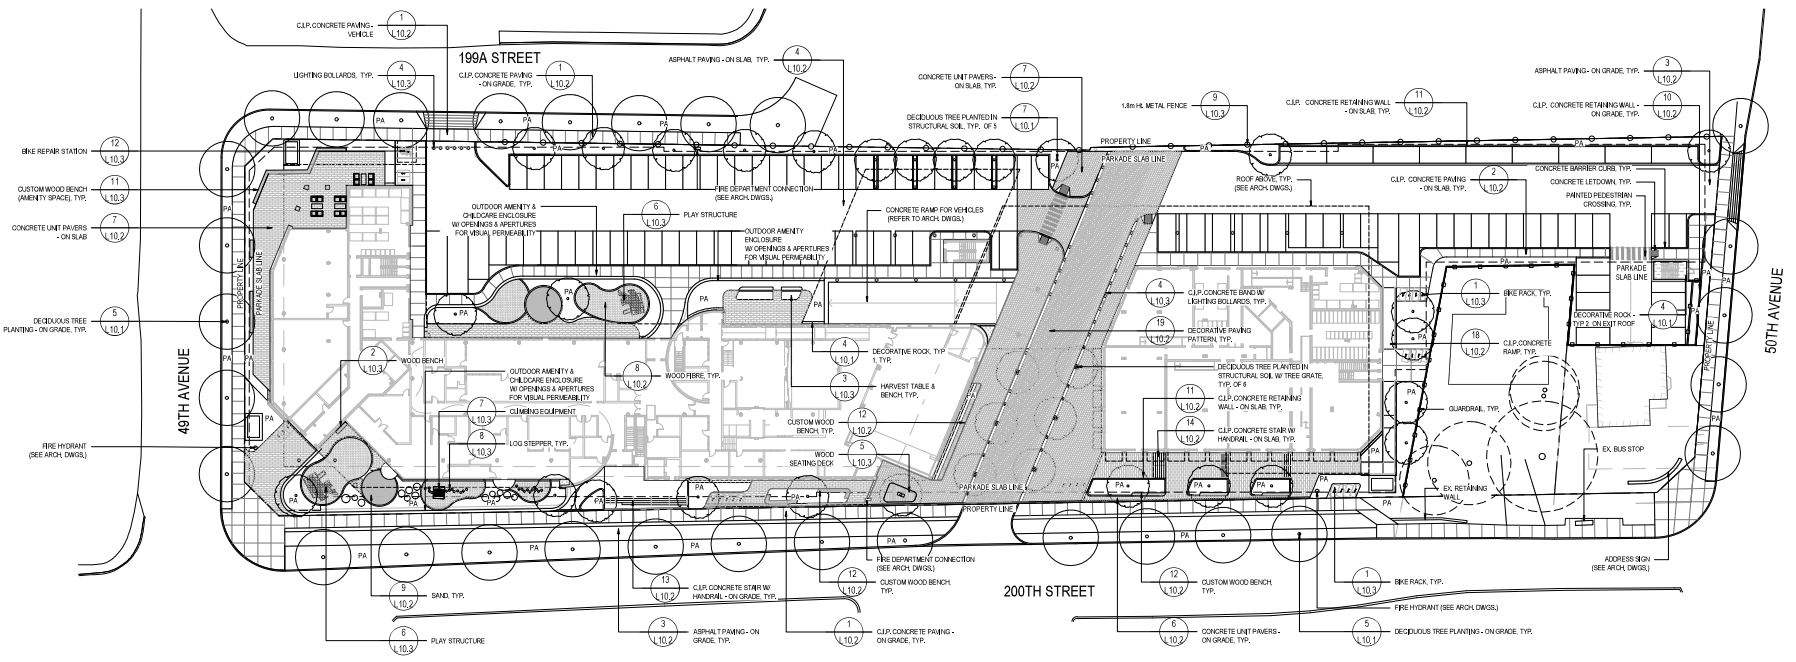

GROUND LEVEL
SCALE: 1/300

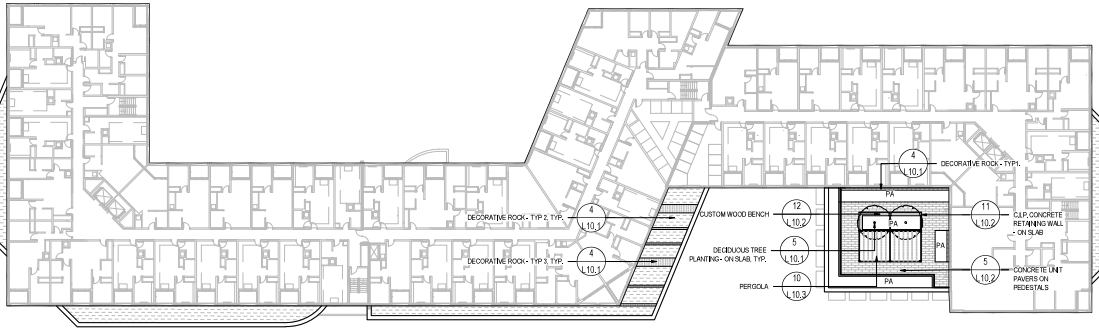

LEVEL 2 - OUTDOOR AMENITY SPACE
SCALE: 1/300

- MATERIALS NOTES:**
- THIS PLAN IS NOT FOR CONSTRUCTION AND IS TO BE SUBMITTED FOR REVIEW TO ENGINEERING SERVICES A MINIMUM OF 4 WEEKS PRIOR TO THE START OF ANY CONSTRUCTION PROPOSED FOR PUBLIC PROPERTY. NO WORK ON PUBLIC PROPERTY MAY BE UNDERTAKEN WITHOUT THE REQUISITE CONSTRUCTION APPROVAL AND RELATED PERMITS ARE ISSUED. PLEASE CONTACT ENGINEERING DEVELOPMENT SERVICES AND/OR YOUR ENGINEERING BUILDING SITE INSPECTOR FOR DETAILS. PROPOSED ROW OF TREES LOCATED ON PRIVATE PROPERTY ADJACENT TO THE PROPERTY LINE ON BARCLAY STREET TO BE MAINTAINED SOLELY ON PRIVATE PROPERTY OR REMOVED.
 - DO NOT SCALE DRAWINGS.
 - LANDSCAPE DRAWINGS ARE TO BE READ IN CONJUNCTION WITH ARCHITECTURAL AND ENGINEERING DRAWINGS. REPORT ANY DISCREPANCIES TO THE CONSULTANT FOR REVIEW AND RESPONSE. REFER TO DETAILS AND SECTIONS FOR ALL LANDSCAPE IMPROVEMENTS.


LEGEND:

	CLP CONCRETE PAVING		EX. TREE TO REMAIN
	CONCRETE UNIT PAVERS		PROPOSED STREET TREE
	WOOD FIBRE		PROPOSED DECEIDUOUS TREE
	SAND		
	DECORATIVE ROCK - TYPE 1		
	DECORATIVE ROCK - TYPE 2		
	DECORATIVE ROCK - TYPE 3		
	SHRUBS, PERENNIALS & GRASSES/PLANTING		

CONCRETE UNIT PAVERS



WOOD BENCH TOP

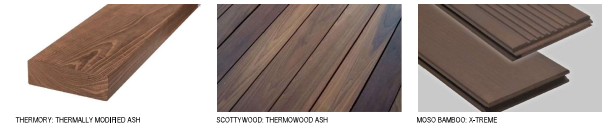

DECORATIVE ROCK



OTHERS



COMPONENT REVISIONS

This sheet and shop plans, and all sheets remain the exclusive property of PFS Studio and cannot be used or reproduced without written consent. Contractors shall verify and be responsible for all dimensions and conditions on the job. This sheet is void if removed from this drawing set without the signature and seal of the Professional Engineer.

NO.	DATE	DESCRIPTION	BY
1	NOV 04, 2024	ISSUED FOR COST ESTIMATE	MM
2	NOV 04, 2024	ISSUED FOR PERMITTING	MM
3	NOV 04, 2024	ISSUED FOR CONSTRUCTION	MM
4	NOV 04, 2024	ISSUED FOR CONSTRUCTION	MM
5	NOV 04, 2024	ISSUED FOR CONSTRUCTION	MM
6	NOV 04, 2024	ISSUED FOR CONSTRUCTION	MM
7	NOV 04, 2024	ISSUED FOR CONSTRUCTION	MM
8	NOV 04, 2024	ISSUED FOR CONSTRUCTION	MM
9	NOV 04, 2024	ISSUED FOR CONSTRUCTION	MM
10	NOV 04, 2024	ISSUED FOR CONSTRUCTION	MM
11	NOV 04, 2024	ISSUED FOR CONSTRUCTION	MM
12	NOV 04, 2024	ISSUED FOR CONSTRUCTION	MM
13	NOV 04, 2024	ISSUED FOR CONSTRUCTION	MM
14	NOV 04, 2024	ISSUED FOR CONSTRUCTION	MM
15	NOV 04, 2024	ISSUED FOR CONSTRUCTION	MM
16	NOV 04, 2024	ISSUED FOR CONSTRUCTION	MM
17	NOV 04, 2024	ISSUED FOR CONSTRUCTION	MM
18	NOV 04, 2024	ISSUED FOR CONSTRUCTION	MM
19	NOV 04, 2024	ISSUED FOR CONSTRUCTION	MM
20	NOV 04, 2024	ISSUED FOR CONSTRUCTION	MM

PROJECT NAME:
PACIFIC NAZARENE HOUSING SOCIETY

DRAWING TITLE:
GROUND LEVEL & LEVEL 2 MATERIALS PLAN

PFS PROJECT NUMBER:
04052

DATE:
NOV06/2024


DRAWN BY:
YY

CHECKED BY:
MM


SCALE:
AS SHOWN

DWG. NO.:
L-3.1

OF:

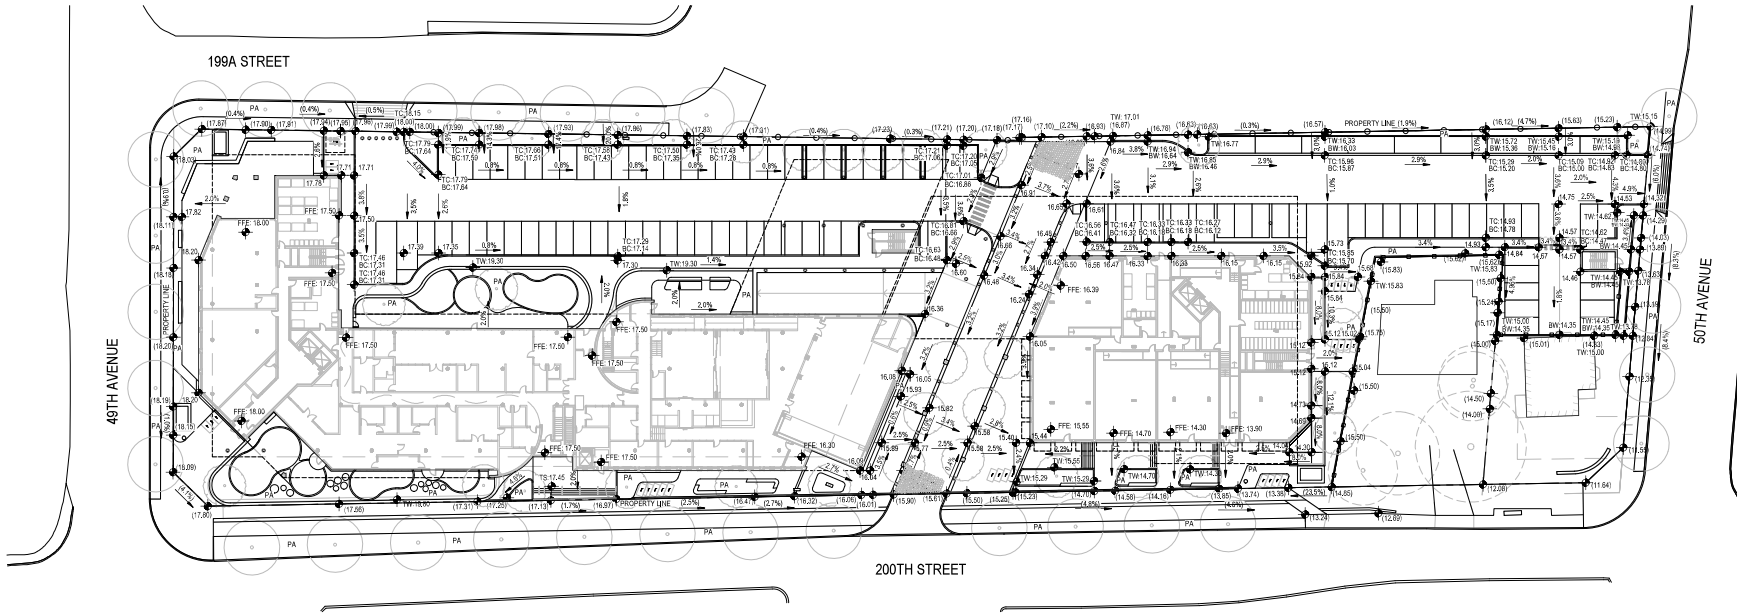

GROUND LEVEL
SCALE: 1:500

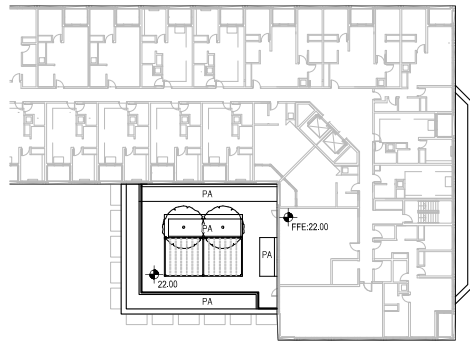

LEVEL 2 - OUTDOOR AMENITY SPACE
SCALE: 1:500

GRADING NOTES:

1. CONFIRM ALL EXISTING GRADES PRIOR TO CONSTRUCTION AND REPORT ANY DISCREPANCIES TO THE CONSULTANT TEAM FOR REVIEW AND RESPONSE.
2. PROVIDE POSITIVE DRAINAGE THROUGHOUT - AWAY FROM BUILDINGS AND TO DRAINAGE STRUCTURES, UNLESS OTHERWISE NOTED. PROVIDE A MINIMUM SLOPE OF 2% ON ALL HARD AND SOFT LANDSCAPE SURFACES.
3. ALL GRADING INFORMATION TO BE COORDINATED WITH ARCHITECTURAL DRAWINGS TO ENSURE ADEQUATE SOIL DEPTHS AND POSITIVE DRAINAGE.

LEGEND:

- EXISTING / GML SPOT ELEVATION
- PROPOSED SPOT ELEVATION
- TOP OF STAIR SPOT ELEVATION
- BOTTOM OF STAIR SPOT ELEVATION
- TOP OF WALL SPOT ELEVATION
- BOTTOM OF WALL SPOT ELEVATION
- TOP OF CURB SPOT ELEVATION
- BOTTOM OF CURB SPOT ELEVATION
- (X)X(X)— SLOPE PERCENTAGE
- TRENCH DRAIN

CONCEPT NOTES:

This plan and other plans, and all other plans, are the property of PFS Studio and shall remain the property of PFS Studio and shall not be used for any other purpose without written consent. Contractors shall verify and be responsible for all dimensions and conditions on the job. This plan is valid for use only for the purpose of the design and construction of the project.

NO.	DATE	DESCRIPTION	BY
1	NOV 06, 2024	ISSUED FOR COST ESTIMATE	MM
2	NOV 06, 2024	ISSUED FOR PERMITTING	MM
3	NOV 06, 2024	ISSUED FOR PERMITTING	MM
4	NOV 06, 2024	ISSUED FOR PERMITTING	MM
5	NOV 06, 2024	ISSUED FOR PERMITTING	MM
6	NOV 06, 2024	ISSUED FOR PERMITTING	MM
7	NOV 06, 2024	ISSUED FOR PERMITTING	MM
8	NOV 06, 2024	ISSUED FOR PERMITTING	MM
9	NOV 06, 2024	ISSUED FOR PERMITTING	MM
10	NOV 06, 2024	ISSUED FOR PERMITTING	MM



PFS STUDIO

STAMP:



PROJECT NAME:
PACIFIC NAZARENE HOUSING SOCIETY

DRAWING TITLE:
GROUND LEVEL & LEVEL 2 GRADING PLAN


PFS PROJECT NUMBER: 24052 DATE: NOV/06/2024

DRAWN BY: YY CHECKED BY: MM


SCALE: AS SHOWN

DWG. NO.:

OF:

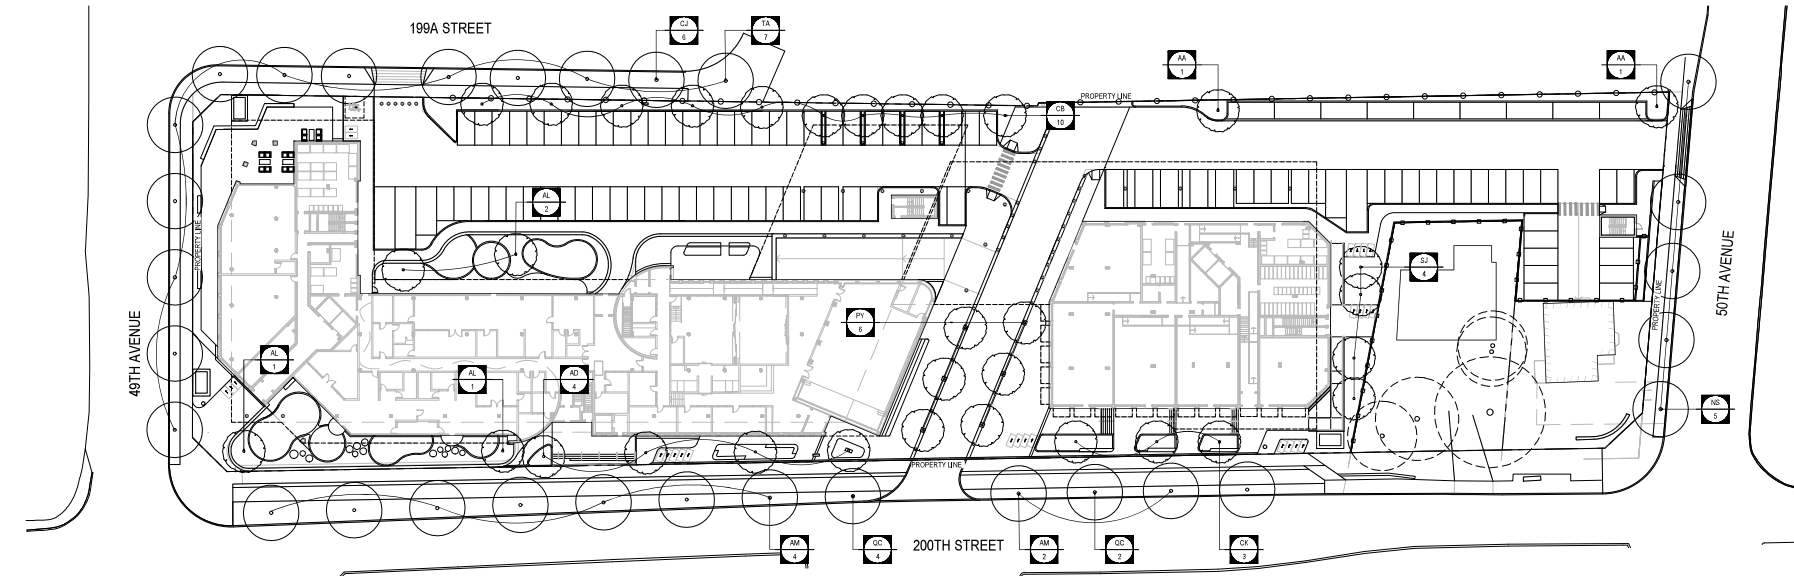

1 GROUND LEVEL
SCALE: 1/250

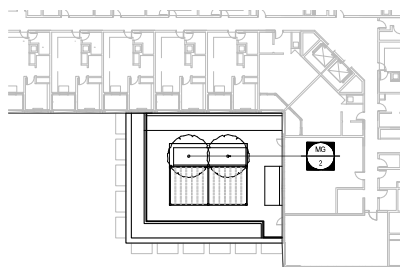

PLANTING NOTES:

1. ALL PLANT MATERIAL SHALL CONFORM TO THE STANDARD SPECIFIED IN THE CURRENT EDITION OF THE BC LANDSCAPE STANDARD. THIS STANDARD IS PUBLISHED JOINTLY BY THE BC SOCIETY OF LANDSCAPE ARCHITECTS (BCLSA) AND THE BC LANDSCAPE AND NURSERY ASSOCIATION (BCLNA).
2. PLANT MATERIAL SPECIES ARE THE MAXIMUM ACCEPTABLE SIZES TO BE SUPPLIED TO THIS PROJECT.
3. ALL PLANT MATERIAL SHALL BE WELL-ESTABLISHED AND UNIFORM IN SHAPE AND SIZE.
4. ALL PLANT MATERIAL SHALL BE NURSERY GROWN UNLESS OTHERWISE NOTED. ONLY CERTIFIED S.O.D. NURSERY STOCK WILL BE ACCEPTED.
5. AUTOMATIC IRRIGATION WILL BE PROVIDED FOR ALL PLANTING AREAS ON SITE. HIGH EFFICIENCY AUTOMATIC IRRIGATION SYSTEM WITH WEATHER SENSOR CONTROLLER WILL BE PROVIDED FOR WATER EFFICIENCY.

PLANT SCHEDULE

TREES					
QTY.	KEY	BOTANICAL NAME	COMMON NAME	SIZE	DESCRIPTION
4	AD	<i>Asa dend.</i>	Snake Bark maple	80CM-1. WE.	FULL, UNIFORM SIZE & QUALITY
2	AR	<i>Asa rubra</i> 'Sinningii'	Amorango maple	80CM-1. WE.	FULL, UNIFORM SIZE & QUALITY
4	AM	<i>Asa rubra</i> 'Meyeri'	Amorango maple	80CM-1. WE.	FULL, UNIFORM SIZE & QUALITY
6	AL	<i>Alnus incana</i>	Allegany sweetbark	2m HT.	FULL, UNIFORM SIZE & QUALITY
10	CB	<i>Carpinus betulus</i> 'Fastigiata'	Pyramidal European hornbeam	80CM-1. WE.	FULL, UNIFORM SIZE & QUALITY
6	CJ	<i>Cercidiphyllum japonicum</i>	Katsura tree	80CM-1. WE.	FULL, UNIFORM SIZE & QUALITY
3	CK	<i>Cornus kousa</i>	Japanese dogwood	80CM-1. WE.	FULL, UNIFORM SIZE & QUALITY
2	MO	<i>Megrelia 'Galeum'</i>	Galeay magnolia	80CM-1. WE.	FULL, UNIFORM SIZE & QUALITY
5	NS	<i>Nyssa sylvatica</i>	Black tupelo	80CM-1. WE.	FULL, UNIFORM SIZE & QUALITY
6	PC	<i>Pinus x yunnan</i> 'Nelsonii'	Nelsons cherry	80CM-1. WE.	FULL, UNIFORM SIZE & QUALITY
4	QY	<i>Quercus acuticarpa</i>	Sweet oak	80CM-1. WE.	FULL, UNIFORM SIZE & QUALITY
4	SJ	<i>Syringa japonica</i>	Japanese snowbell	80CM-1. WE.	FULL, UNIFORM SIZE & QUALITY
7	TA	<i>Tilia amurensis</i> 'Redmond'	Redmond linden	80CM-1. WE.	FULL, UNIFORM SIZE & QUALITY

2 LEVEL 2 - OUTDOOR AMENITY SPACE
SCALE: 1/200

TREES



Acer distichum



Acer rubrum 'Armstrong'



Amelanchier laevis



Acer rubrum 'Morgan'



Carpinus betulus 'Fastigata'



Cercidiphyllum japonicum




Cornus florida



Magnolia 'Galea'



Fluxus media

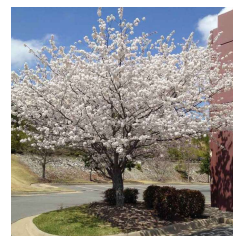

Answer to question 3: Akbar



Quelques remarques



Super Japanese



The modern Bedouin



STAMP



PROJECT NAME:
PACIFIC NAZARENE
HOUSING SOCIETY

DRAWING TITLE:
GROUND LEVEL &
LEVEL 2 PLANTING PLAN

PFS PROJECT NUMBER:	DATE:
24032	NOV05/2003

DRAWN BY: _____ CHECKED BY: _____

SCALE:
AS SHOWN

D/WG. NO.:

L-6.1


OF:

CONCEPT RESPONSE

This plan and design are, and all shall remain the exclusive property of PFS Studio and cannot be used or reproduced without written consent. Contractors and other parties responsible for all measures and conditions on the job. This plan is valid for reference only and does not constitute a contract or a binding agreement.

REVISIONS

NO.	DATE	DESCRIPTION	BY
1	NOV 04, 2024	PROPOSED FOR CONCEPT	MM
2	NOV 04, 2024	PROPOSED FOR CONCEPT	MM
3	NOV 04, 2024	PROPOSED FOR CONCEPT	MM
100	NOV 04, 2024	PROPOSED FOR CONCEPT	MM

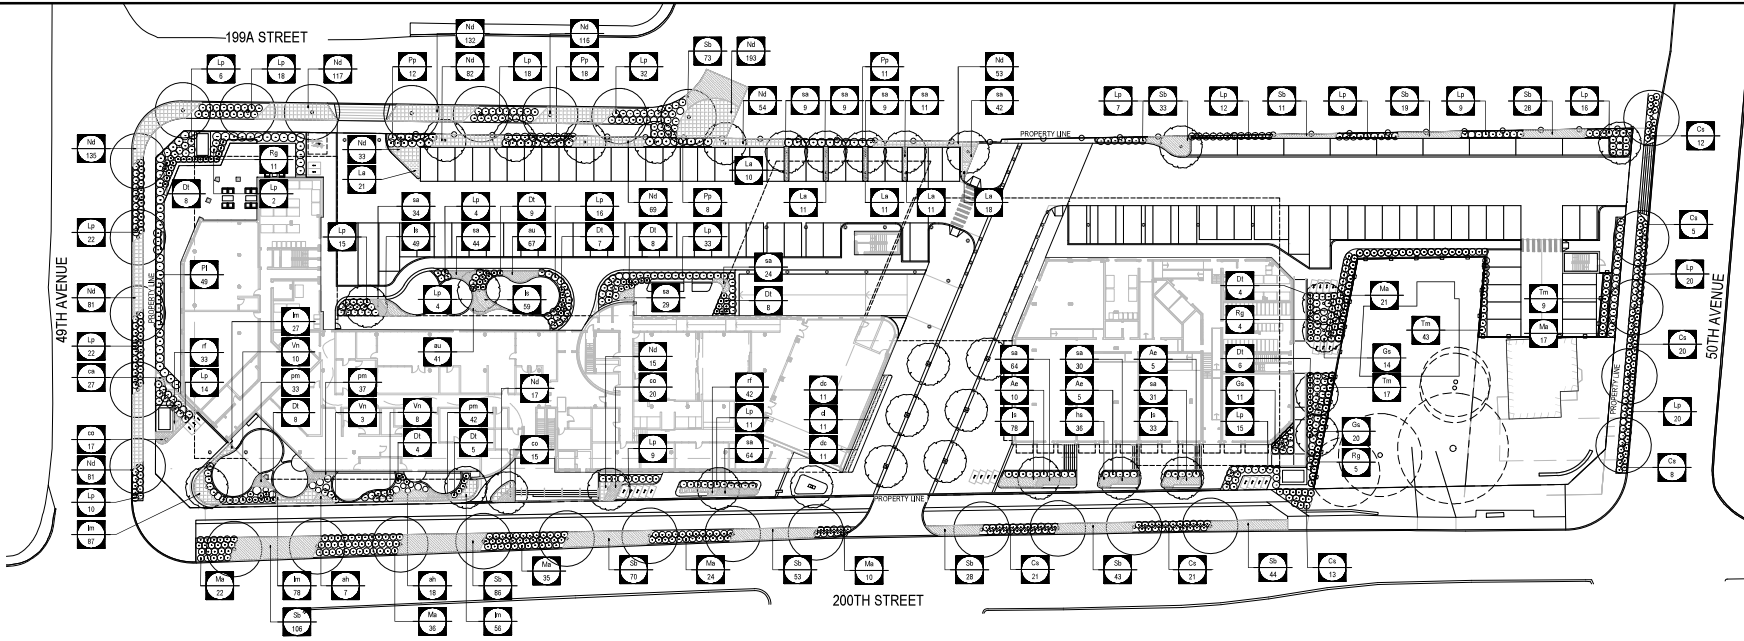

GROUND LEVEL
SCALE: 1:50

PLANT SCHEDULE

SHRUBS					
QTY.	KEY	BOTANICAL NAME	COMMON NAME	SIZE	DESCRIPTION
40	Ae	Abelia 'Edward Goucher'	Pink Abelia	#2 POT	1.0M O.C.
100	Cs	Corus serotina 'Farrow'	Arctic Fire red twig dogwood	#2 POT	1.0M O.C.
67	Ds	Daphne transatlantica 'BLAFRA'	Eternal fragrance daphne	#2 POT	0.9M O.C.
45	Ga	Gaultheria shallon	Saltol	#2 POT	1.0M O.C.
82	Ls	Lavandula angustifolia 'Hidcot'	Lavender	#1 POT	0.9M O.C.
344	Lp	Lonicera japonica	Privet honeysuckle	#2 POT	0.9M O.C.
185	Ma	Mahonia aquifolium 'Compactum'	Oregon grape	#2 POT	1.0M O.C.
1178	Nd	Nandina domestica 'Fire Power'	Fire Power Nandina	#2 POT	0.6M O.C.
49	Pp	Pinus pungens 'Bibboid'	Colorado spruce	#2 POT	1.2M O.C.
72	Pl	Platanus latifolia 'Lobli'	Little Portugal laurel	#1 POT	1.2M O.C.
20	Rg	Rhododendron 'Gumpo White'	Gumpo White Azalea	#2 POT	1.0M O.C.
594	Ss	Spiraea betulifolia	Betulaifolia spirea	#2 POT	0.8M O.C.
69	Tm	Taxus media 'Hicks'	Yew	#2 POT	1.0M O.C.
PERENNIALS					
QTY.	KEY	BOTANICAL NAME	COMMON NAME	SIZE	DESCRIPTION
196	au	Agastache aurantiaca 'Apricot Spice'	Apricot Spice hyssop	#1 POT	0.3M O.C.
25	ah	Arenaria x hybrida 'September Charm'	Arenaria	#1 POT	0.6M O.C.

36	hs	Hemerocallis 'Stella de Oro'	Daylily	#1 POT	0.3M O.C.
219	ls	Liatris spicata 'Kobold'	Blazing star	#1 POT	0.3M O.C.
112	pm	Polystichum munsonii	Sword fern	#1 POT	0.3M O.C.
75	rl	Rubus idaeus 'Goldflame'	Goldflame currant	#1 POT	0.3M O.C.
GRASSES					
QTY.	KEY	BOTANICAL NAME	COMMON NAME	SIZE	DESCRIPTION
27	ca	Calamagrostis x acutiflora 'Karl Foerster'	Feather reed grass	#1 POT	0.45M O.C.
52	ca	Carex ostenensis 'Everbl'	Japanese sedge	#1 POT	0.45M O.C.
11	cl	Chamaenerion albidum	Northern Sea Oats	#1 POT	0.45M O.C.
22	do	Deschampsia cespitosa	Tufted Hair grass	#1 POT	0.45M O.C.
248	lm	Liriodendron 'Big Blue'	Big Blue Lily turf	#1 POT	0.3M O.C.
39	ms	Mosses albaea 'Gracilimus'	Chinese Silver grass	#1 POT	0.6M O.C.
407	sa	Sesuvium portuacastrum	Autumn Moor grass	#1 POT	0.3M O.C.
EDIBLE PLANTS					
QTY.	KEY	BOTANICAL NAME	COMMON NAME	SIZE	DESCRIPTION
21	Vn	Vaccinium Northcountry'	Northcountry blueberry	#2 POT	0.3M O.C.

SHRUBS, PERENNIALS & GRASSES:



Abelia 'Edward Goucher'



Corus serotina 'Farrow'



Daphne transatlantica 'BLAFRA'



Gaultheria shallon



Lavandula angustifolia 'Hidcot'



Lonicera japonica



Mahonia aquifolium 'Compactum'



Nandina domestica 'Fire Power'



Pinus pungens 'Bibboid'



Platanus latifolia 'Lobli'



Rhododendron 'Gumpo White'




Spiraea betulifolia



Taxus media 'Hicks'



Agastache aurantiaca 'Apricot Spice'

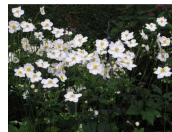

Arenaria x hybrida 'September Charm'



Hemerocallis 'Stella de Oro'



Liatris spicata 'Kobold'



Polystichum munsonii



Rubus idaeus 'Goldflame'



Calamagrostis x acutiflora 'Karl Foerster'



Carex ostenensis 'Everbl'



Chamaenerion albidum



Deschampsia cespitosa



Liriodendron 'Big Blue'



 
Mosses albaea 'Gracilimus'



Sesuvium portuacastrum



Vaccinium Northcountry'



PFS STUDIO

STAMP:



PROJECT NAME:
PACIFIC NAZARENE
HOUSING SOCIETY


DRAWING TITLE:
GROUND LEVEL &
LEVEL 2 PLANTING PLAN

PFS PROJECT NUMBER: 44052 DATE: NOV/05/2024


DRAWN BY: YY CHECKED BY: MM

SCALE: AS SHOWN

DWG. NO.: L-6.2 OF:

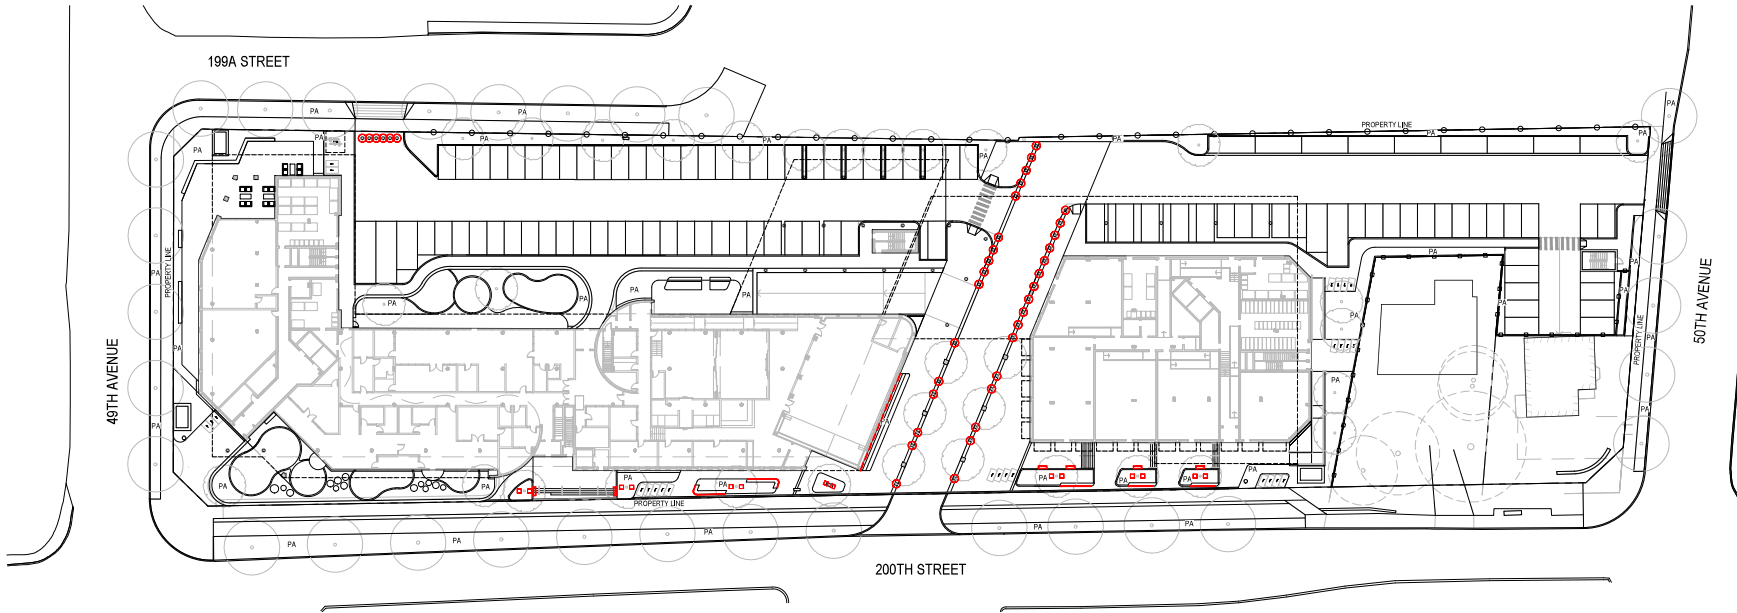

GROUND LEVEL
SCALE: 1:500

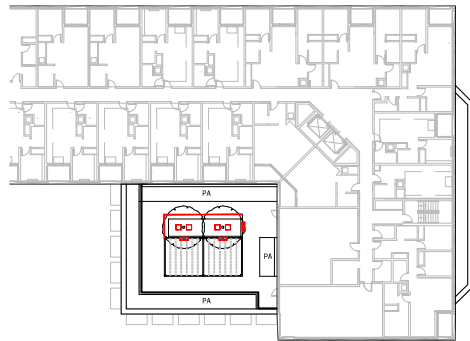

LEVEL 2 - OUTDOOR AMENITY SPACE
SCALE: 1:500

LIGHTING NOTES:

1. THIS DRAWING IS FOR REFERENCE ONLY.

LEGEND:

- LINEAR LED LIGHT
- IN-GROUND UPLIGHT
- BOLLARD LIGHT
- ▭ WALL LIGHT
- - - WALL UPLIGHT

CONCEPT RESOURCES

This plan and design are, and it is deemed to be, the exclusive property of PFS Studio and cannot be used or reproduced without written consent. Contractors and other parties responsible for all construction and installation on the job. This plan is valid only as shown, and any discrepancies between the drawings and conditions shall prevail.

NO.	DATE	DESCRIPTION	BY
1	NOV 04, 2024	PROJECT START / CONCEPT	PA
2	NOV 04, 2024	PROJECT START / CONCEPT	PA
3	NOV 04, 2024	PROJECT START / CONCEPT	PA
4	NOV 04, 2024	PROJECT START / CONCEPT	PA
5	NOV 04, 2024	PROJECT START / CONCEPT	PA
6	NOV 04, 2024	PROJECT START / CONCEPT	PA
7	NOV 04, 2024	PROJECT START / CONCEPT	PA
8	NOV 04, 2024	PROJECT START / CONCEPT	PA
9	NOV 04, 2024	PROJECT START / CONCEPT	PA
10	NOV 04, 2024	PROJECT START / CONCEPT	PA



PFS STUDIO

STAMP:



PROJECT NAME:
**PACIFIC NAZARENE
HOUSING SOCIETY**

 
DRAWING TITLE:
**GROUND LEVEL & LEVEL 2
SCHEMATIC LIGHTING PLAN**

PFS PROJECT NUMBER: 24052 DATE: NOV/06/2024

DRAWN BY: YY CHECKED BY: NM


SCALE: AS SHOWN

DWG. NO. L-8.1 OF:



BUDGET			
Yr	Date	Grub	St
1	NOV 06, 2024	PAID FOR 2024 EXPENSE	00
2	NOV 06, 2024	PAID FOR RENTED GRP	00
3	DEC 01, 2024	PAID FOR RENTED GRP	00
4	JAN 01, 2025	PAID FOR 2025 EXPENSE	00
5	JAN 01, 2025	PAID FOR RENTED GRP	00
6	MAY 14, 2025	PAID FOR RENTED GRP	00

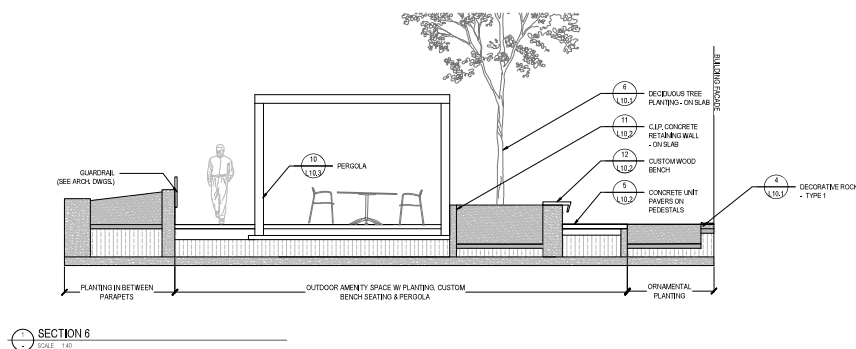

[illegible]

PFS STUDIO

STAMP



PROJECT NAME:
**PACIFIC NAZARENE
HOUSING SOCIETY**

DRAWING TITLE:
SECTIONS

PFS PROJECT NUMBER:	DATE:
24032	NOV06/2024


DRAWN BY: YY CHECKED BY: NM

SCALE:
AS SHOWN


CINO NO:

L-9.2


OF:

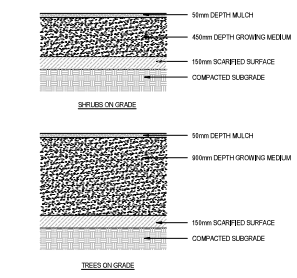


SOIL PROFILES - ON GRADE
SCALE: 1:20

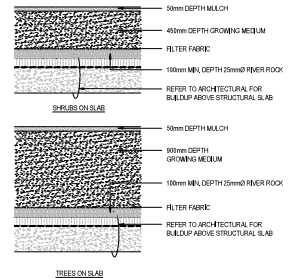


SOIL PROFILES - ON SLAB
SCALE: 1:20

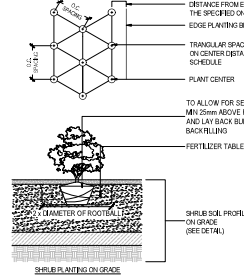


SHRUBS PLANTING
SCALE: 1:20

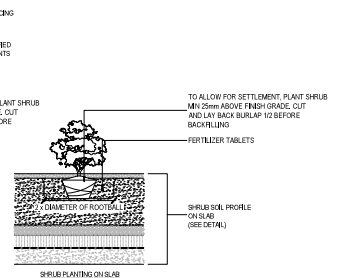


SHRUB PLANTING ON SLAB
SCALE: 1:20

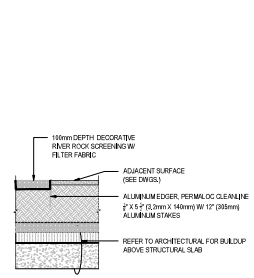


DECORATIVE ROCK
SCALE: 1:20

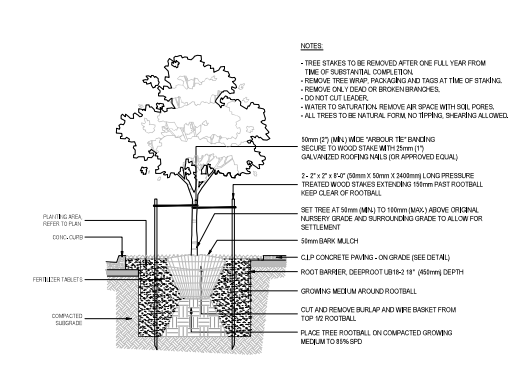

DECIDUOUS TREE PLANTING - ON GRADE
SCALE: 1:20

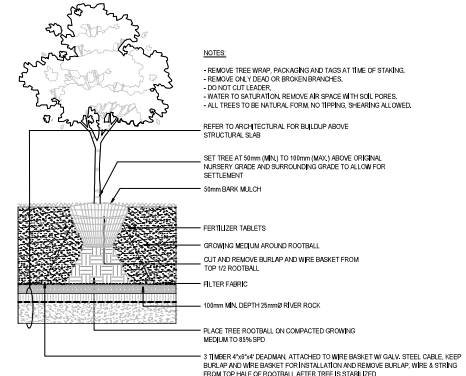

DECIDUOUS TREE PLANTING - ON SLAB
SCALE: 1:20

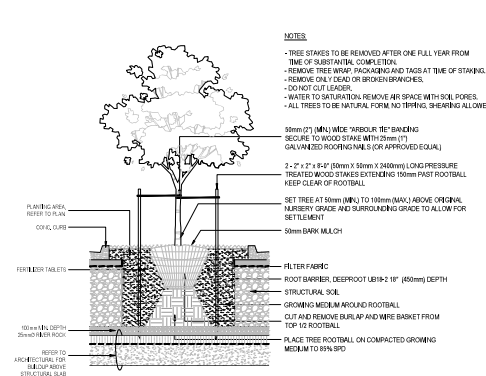

DECIDUOUS TREE PLANTING IN STRUCTURAL SOIL
SCALE: 1:20

COMPONENTS

This plan and detail are, and all shall remain the exclusive property of PFS Studio and cannot be used or reproduced without written consent. Contractors shall verify and be responsible for all dimensions and conditions in the job. The client shall be responsible for any discrepancies from the dimensions and conditions stated herein.

NO.	DATE	DESCRIPTION	BY
1	NOV 04, 2024	ISSUED FOR COST ESTIMATE	MM
2	NOV 04, 2024	ISSUED FOR PERMITTING	MM
3	NOV 04, 2024	ISSUED FOR PERMITTING	MM
4	NOV 04, 2024	ISSUED FOR PERMITTING	MM
5	NOV 04, 2024	ISSUED FOR PERMITTING	MM
6	NOV 04, 2024	ISSUED FOR PERMITTING	MM
7	NOV 04, 2024	ISSUED FOR PERMITTING	MM
8	NOV 04, 2024	ISSUED FOR PERMITTING	MM
9	NOV 04, 2024	ISSUED FOR PERMITTING	MM
10	NOV 04, 2024	ISSUED FOR PERMITTING	MM
11	NOV 04, 2024	ISSUED FOR PERMITTING	MM
12	NOV 04, 2024	ISSUED FOR PERMITTING	MM
13	NOV 04, 2024	ISSUED FOR PERMITTING	MM
14	NOV 04, 2024	ISSUED FOR PERMITTING	MM
15	NOV 04, 2024	ISSUED FOR PERMITTING	MM
16	NOV 04, 2024	ISSUED FOR PERMITTING	MM
17	NOV 04, 2024	ISSUED FOR PERMITTING	MM
18	NOV 04, 2024	ISSUED FOR PERMITTING	MM
19	NOV 04, 2024	ISSUED FOR PERMITTING	MM
20	NOV 04, 2024	ISSUED FOR PERMITTING	MM



PROJECT NAME:
PACIFIC NAZARENE
HOUSING SOCIETY

DRAWING TITLE:
LANDSCAPE
DETAILS

PFS PROJECT NUMBER:
24052

DATE:
NOV06/2024

 
DRAWN BY:
YY

CHECKED BY:
MM


SCALE:
AS SHOWN

DWG. NO.
L-10.1


OF:
10



 
VEHICLE
C.I.P. CONCRETE PAVING - ON GRADE
SCALE: 1:20



PEDESTRIAN

 

 
C.I.P. CONCRETE PAVING - ON SLAB
SCALE: 1:20




EXPANSION JOINT - TYPICAL
SCALE: 1:10




SAWCUT JOINT - TYPICAL
SCALE: 1:10

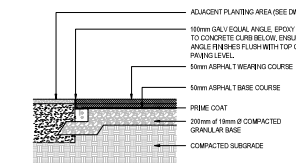


ASPHALT PAVING - ON GRADE
SCALE: 1:20

 


ASPHALT PAVING - ON SLAB
SCALE: 1:20

 


CONCRETE UNIT PAVERS ON PEDESTALS
SCALE: 1:20

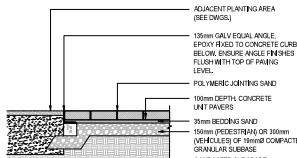


CONCRETE UNIT PAVERS - ON GRADE
SCALE: 1:20

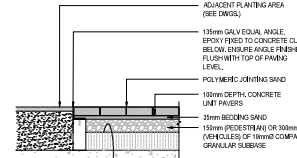


CONCRETE UNIT PAVERS - ON SLAB
SCALE: 1:20

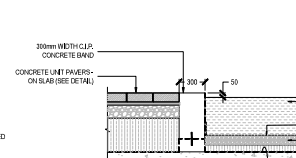


WOOD FIBRE
SCALE: 1:20

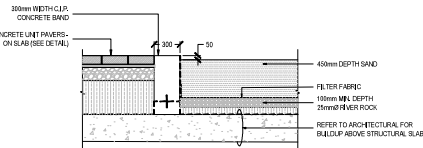


SAND
SCALE: 1:20

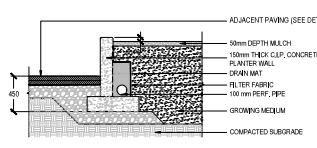


C.I.P. CONCRETE RETAINING WALL - ON GRADE
SCALE: 1:20

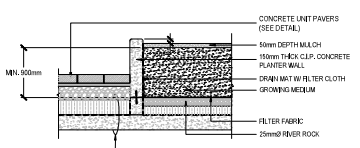


C.I.P. CONCRETE RETAINING WALL / CURB - ON SLAB
SCALE: 1:20

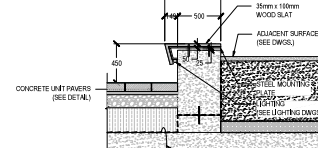


CUSTOM WOOD BENCH
SCALE: 1:20

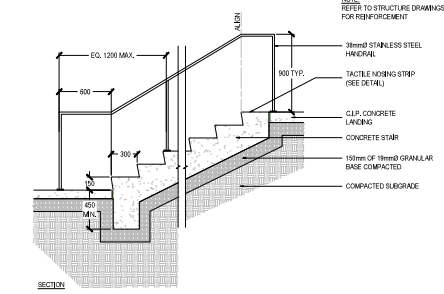


C.I.P. CONCRETE STAIR W/ HANDRAIL - ON GRADE
SCALE: 1:20

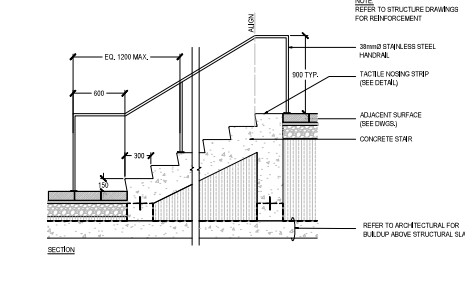


C.I.P. CONCRETE STAIR W/ HANDRAIL - ON SLAB
SCALE: 1:20

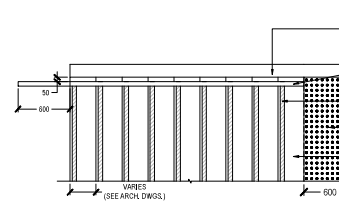


TACTILE NOSING STRIP
SCALE: 1:20

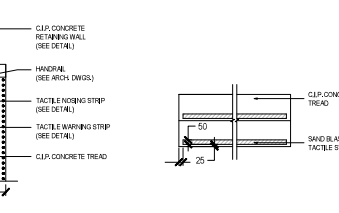


TACTILE NOSING STRIP
SCALE: 1:20

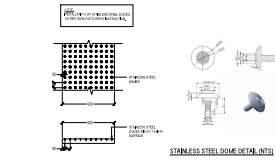


TACTILE WARNING STRIP
SCALE: 1:20

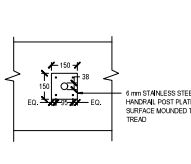


HANDRAIL POST CONNECTION
SCALE: 1:20

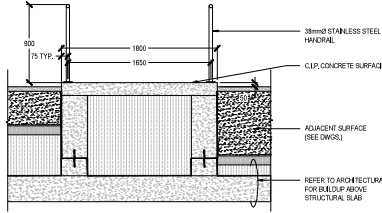

C.I.P. CONCRETE RAMP
SCALE: 1:20

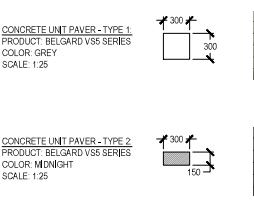

DECORATIVE PAVING PATTERN
SCALE: 1:20

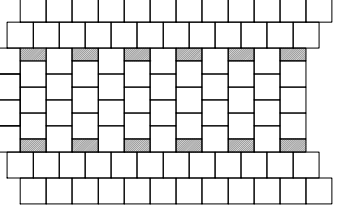


PAVING PATTERN
SCALE: 1:20

CONTRACT REVISIONS

This sheet and shop drawings, and all others remain the exclusive property of PFS Studio and cannot be used or reproduced without written consent. Contractors shall verify and be responsible for all dimensions and conditions on the job. This sheet is valid for use only for the project and location specified on the drawing and conditions of use.

NO.	DATE	DESCRIPTION	BY
1	NOV 2024	ISSUED FOR COST ESTIMATE	MM
2	NOV 2024	ISSUED FOR PERMITTING	MM
3	NOV 2024	ISSUED FOR PERMITTING	MM
4	NOV 2024	ISSUED FOR PERMITTING	MM
5	NOV 2024	ISSUED FOR PERMITTING	MM
6	NOV 2024	ISSUED FOR PERMITTING	MM
7	NOV 2024	ISSUED FOR PERMITTING	MM
8	NOV 2024	ISSUED FOR PERMITTING	MM
9	NOV 2024	ISSUED FOR PERMITTING	MM
10	NOV 2024	ISSUED FOR PERMITTING	MM
11	NOV 2024	ISSUED FOR PERMITTING	MM
12	NOV 2024	ISSUED FOR PERMITTING	MM
13	NOV 2024	ISSUED FOR PERMITTING	MM
14	NOV 2024	ISSUED FOR PERMITTING	MM
15	NOV 2024	ISSUED FOR PERMITTING	MM
16	NOV 2024	ISSUED FOR PERMITTING	MM
17	NOV 2024	ISSUED FOR PERMITTING	MM
18	NOV 2024	ISSUED FOR PERMITTING	MM
19	NOV 2024	ISSUED FOR PERMITTING	MM
20	NOV 2024	ISSUED FOR PERMITTING	MM



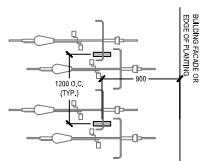

PLAN VIEW



SAMPLE PHOTO



BIKE RACK

SCALE: 1/2"




SAMPLE PHOTO



WOOD BENCH

SCALE: 1/4"

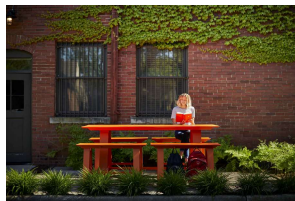

SAMPLE PHOTO



HARVEST TABLE & BENCH

SCALE: 1/4"



SAMPLE PHOTO



LIGHTING BOLLARD

SCALE: 1/4"




SAMPLE PHOTO



WOOD SEATING DECK

SCALE: 1/4"

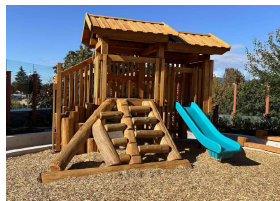

SAMPLE PHOTO



PLAY STRUCTURE

SCALE: 1/4"



SAMPLE PHOTO



CLIMBING EQUIPMENT

SCALE: 1/4"



SAMPLE PHOTO



LOG STEPPER

SCALE: 1/4"




SAMPLE PHOTO



1.8m Hx METAL FENCE

SCALE: 1/4"

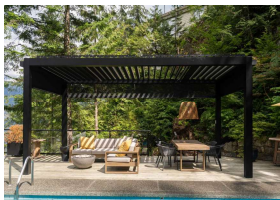

SAMPLE PHOTO

 


PERGOLA

SCALE: 1/4"



SAMPLE PHOTO



CUSTOM WOOD BENCH (AMENITY SPACE)

SCALE: 1/4"



SAMPLE PHOTO



BIKE REPAIR STATION

SCALE: 1/4"

COMPONENT REVISIONS

This plan and design are, and at all times remain the exclusive property of PFS Studio and cannot be used or reproduced without written consent. Contractors shall verify and be responsible for all dimensions and conditions on the job. The client shall be responsible for any discrepancies from the drawings and conditions stated herein.

REVISIONS

NO.	DATE	DESCRIPTION	BY
1	NOV 08, 2024	REVISION FOR COST ESTIMATE	NM
2	NOV 08, 2024	REVISION FOR MATERIALS	NM
3	NOV 08, 2024	REVISION FOR MATERIALS	NM
4	NOV 08, 2024	REVISION FOR MATERIALS	NM
5	NOV 08, 2024	REVISION FOR MATERIALS	NM
6	NOV 08, 2024	REVISION FOR MATERIALS	NM
7	NOV 08, 2024	REVISION FOR MATERIALS	NM
8	NOV 08, 2024	REVISION FOR MATERIALS	NM
9	NOV 08, 2024	REVISION FOR MATERIALS	NM
10	NOV 08, 2024	REVISION FOR MATERIALS	NM
11	NOV 08, 2024	REVISION FOR MATERIALS	NM
12	NOV 08, 2024	REVISION FOR MATERIALS	NM
13	NOV 08, 2024	REVISION FOR MATERIALS	NM
14	NOV 08, 2024	REVISION FOR MATERIALS	NM
15	NOV 08, 2024	REVISION FOR MATERIALS	NM
16	NOV 08, 2024	REVISION FOR MATERIALS	NM
17	NOV 08, 2024	REVISION FOR MATERIALS	NM
18	NOV 08, 2024	REVISION FOR MATERIALS	NM
19	NOV 08, 2024	REVISION FOR MATERIALS	NM
20	NOV 08, 2024	REVISION FOR MATERIALS	NM



PFS STUDIO

STAMP:



PROJECT NAME:
**PACIFIC NAZARENE
HOUSING SOCIETY**

DRAWING TITLE:
**LANDSCAPE
DETAILS**

PFS PROJECT NUMBER: 24052 DATE: NOV 06/2024

DRAWN BY: YY CHECKED BY: NM

SCALE:
AS SHOWN

DWG. NO.

L-10.3

OF: